




PROJECT TITLE	LOCATION	NOTE	DRAWING TITLE	SCALE	DRAWING BY	DRAWING NO.
				Non		
	노원어린이극장		전체 평면도	DATE	Nomess Stage	SHEET NO.
				2023.08.26		

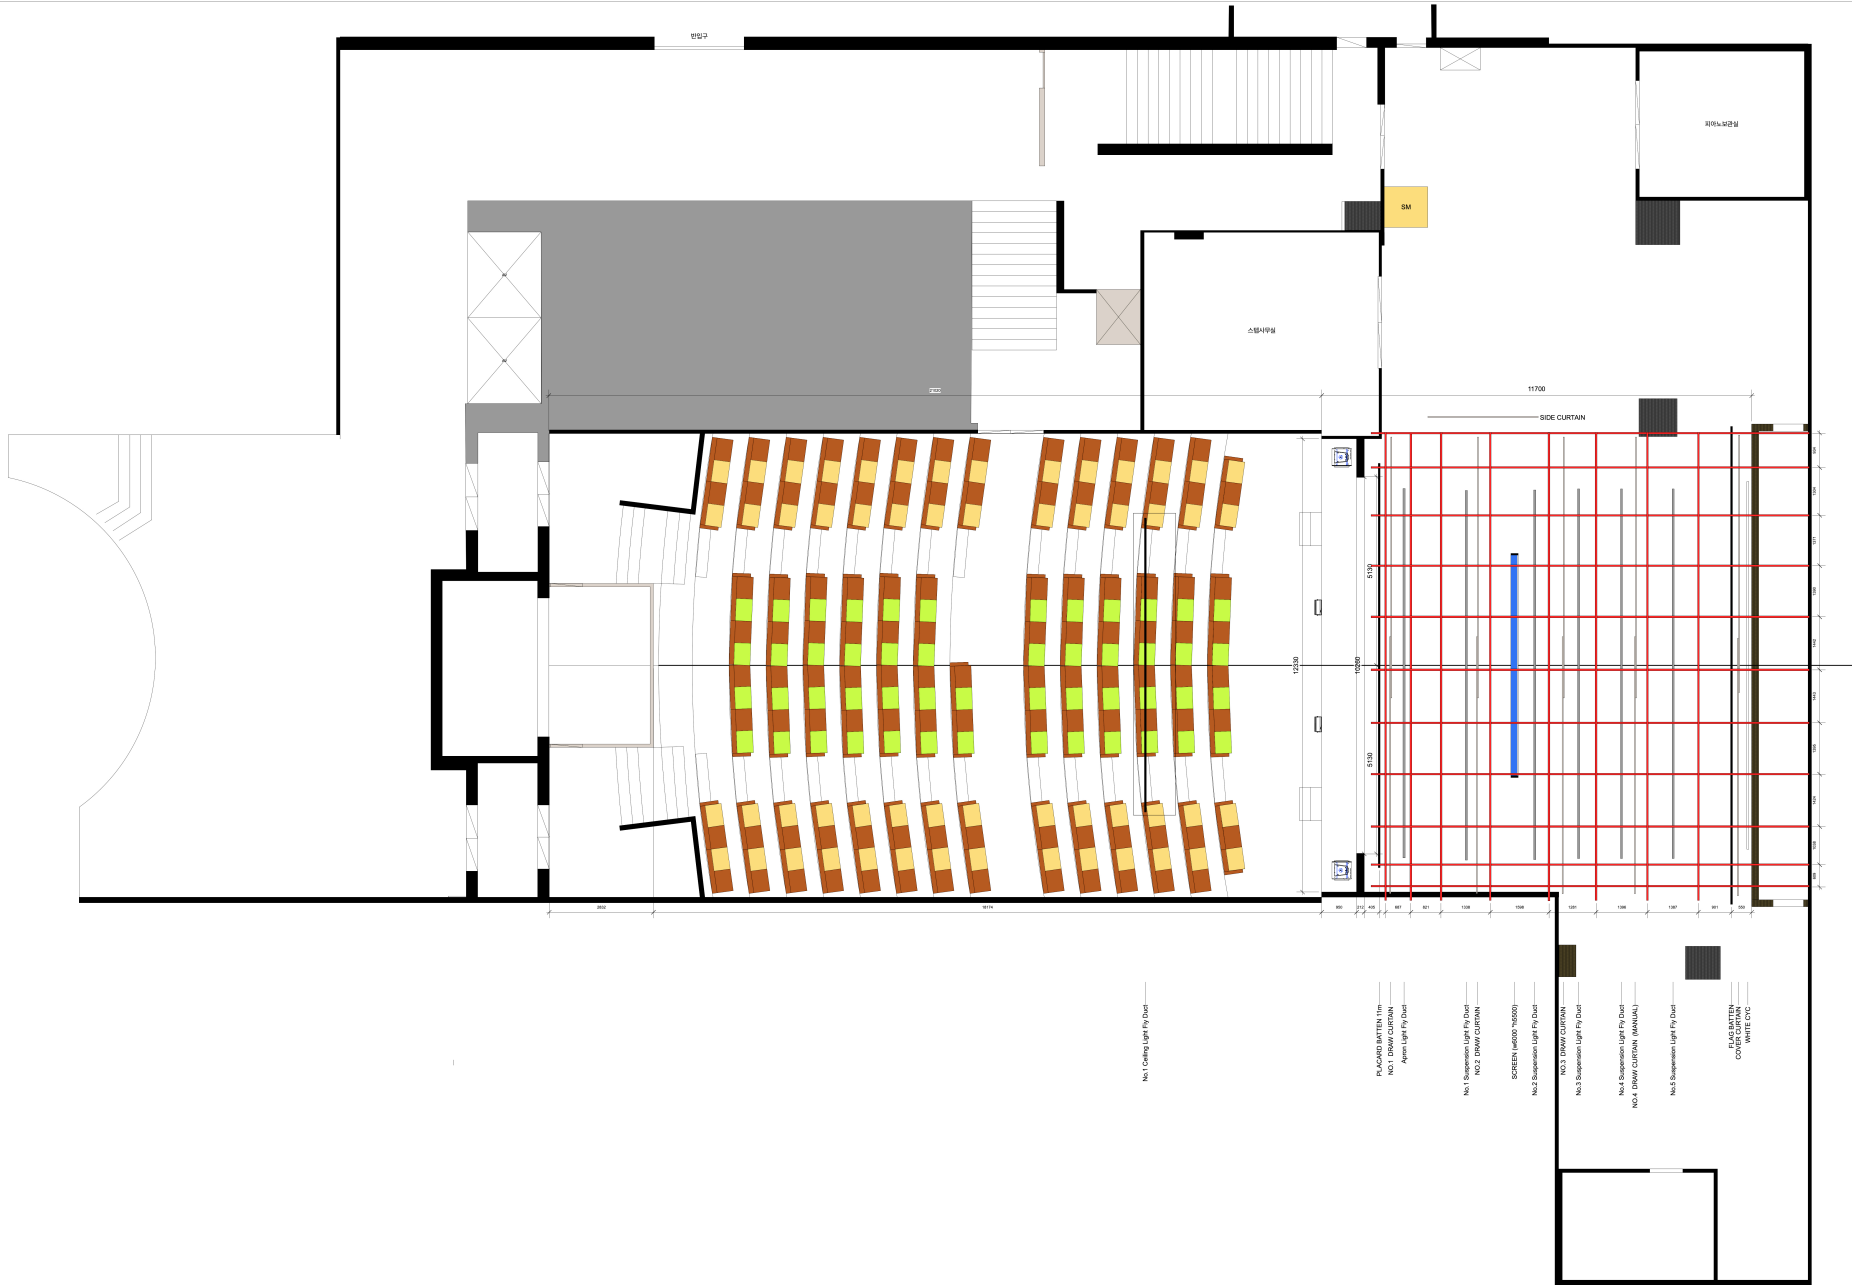


PROJECT TITLE	LOCATION	NOTE	DRAWING TITLE	SCALE	DRAWING BY	DRAWING NO.
	노원어린이극장		전체 평면도	Non	Nomess Stage	
				DATE		SHEET NO.
				2023.08.26		

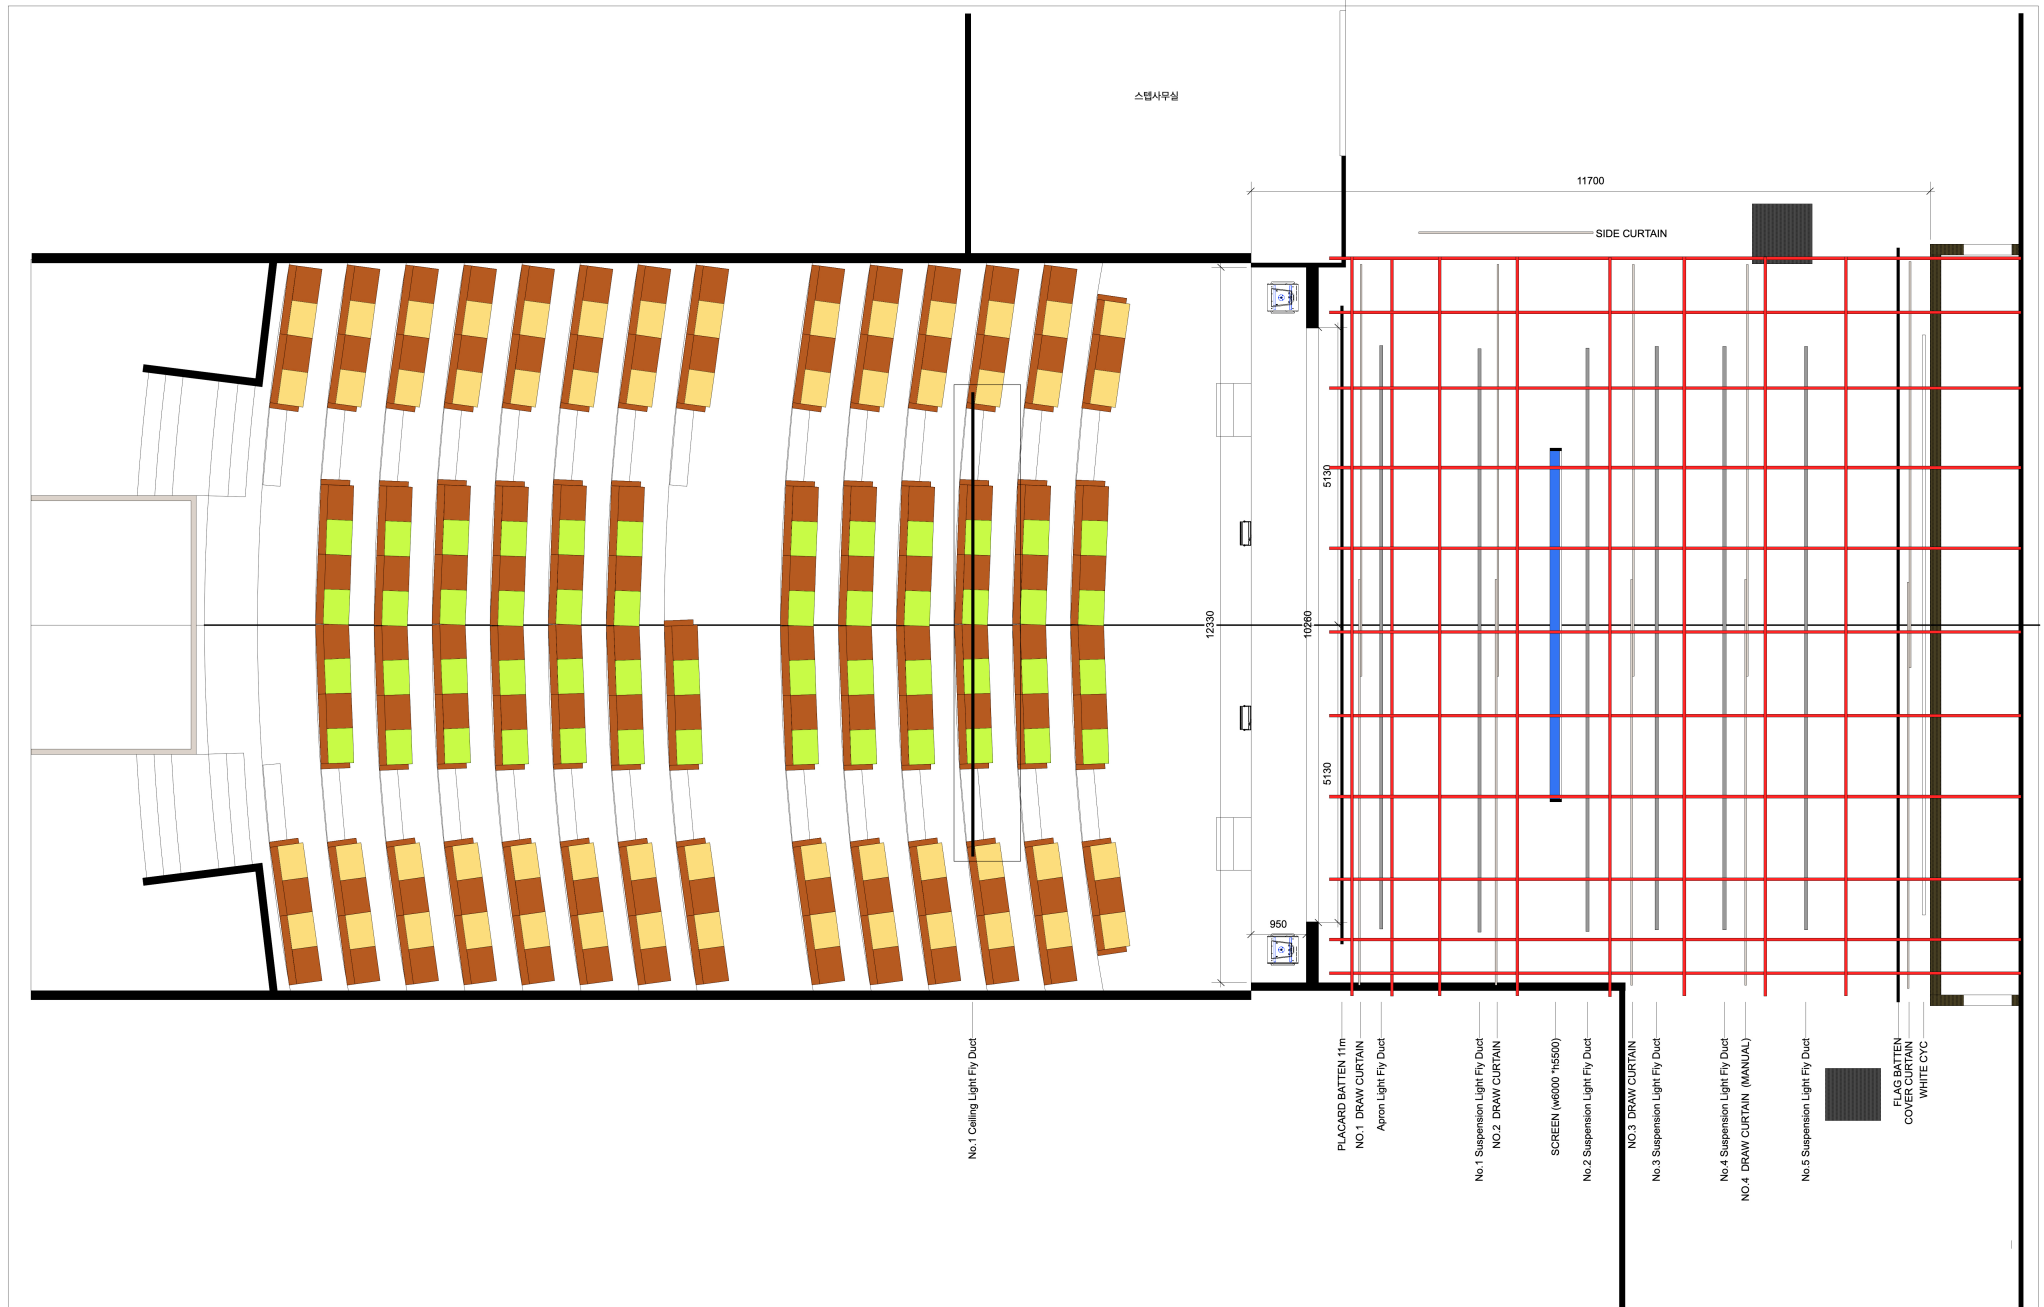


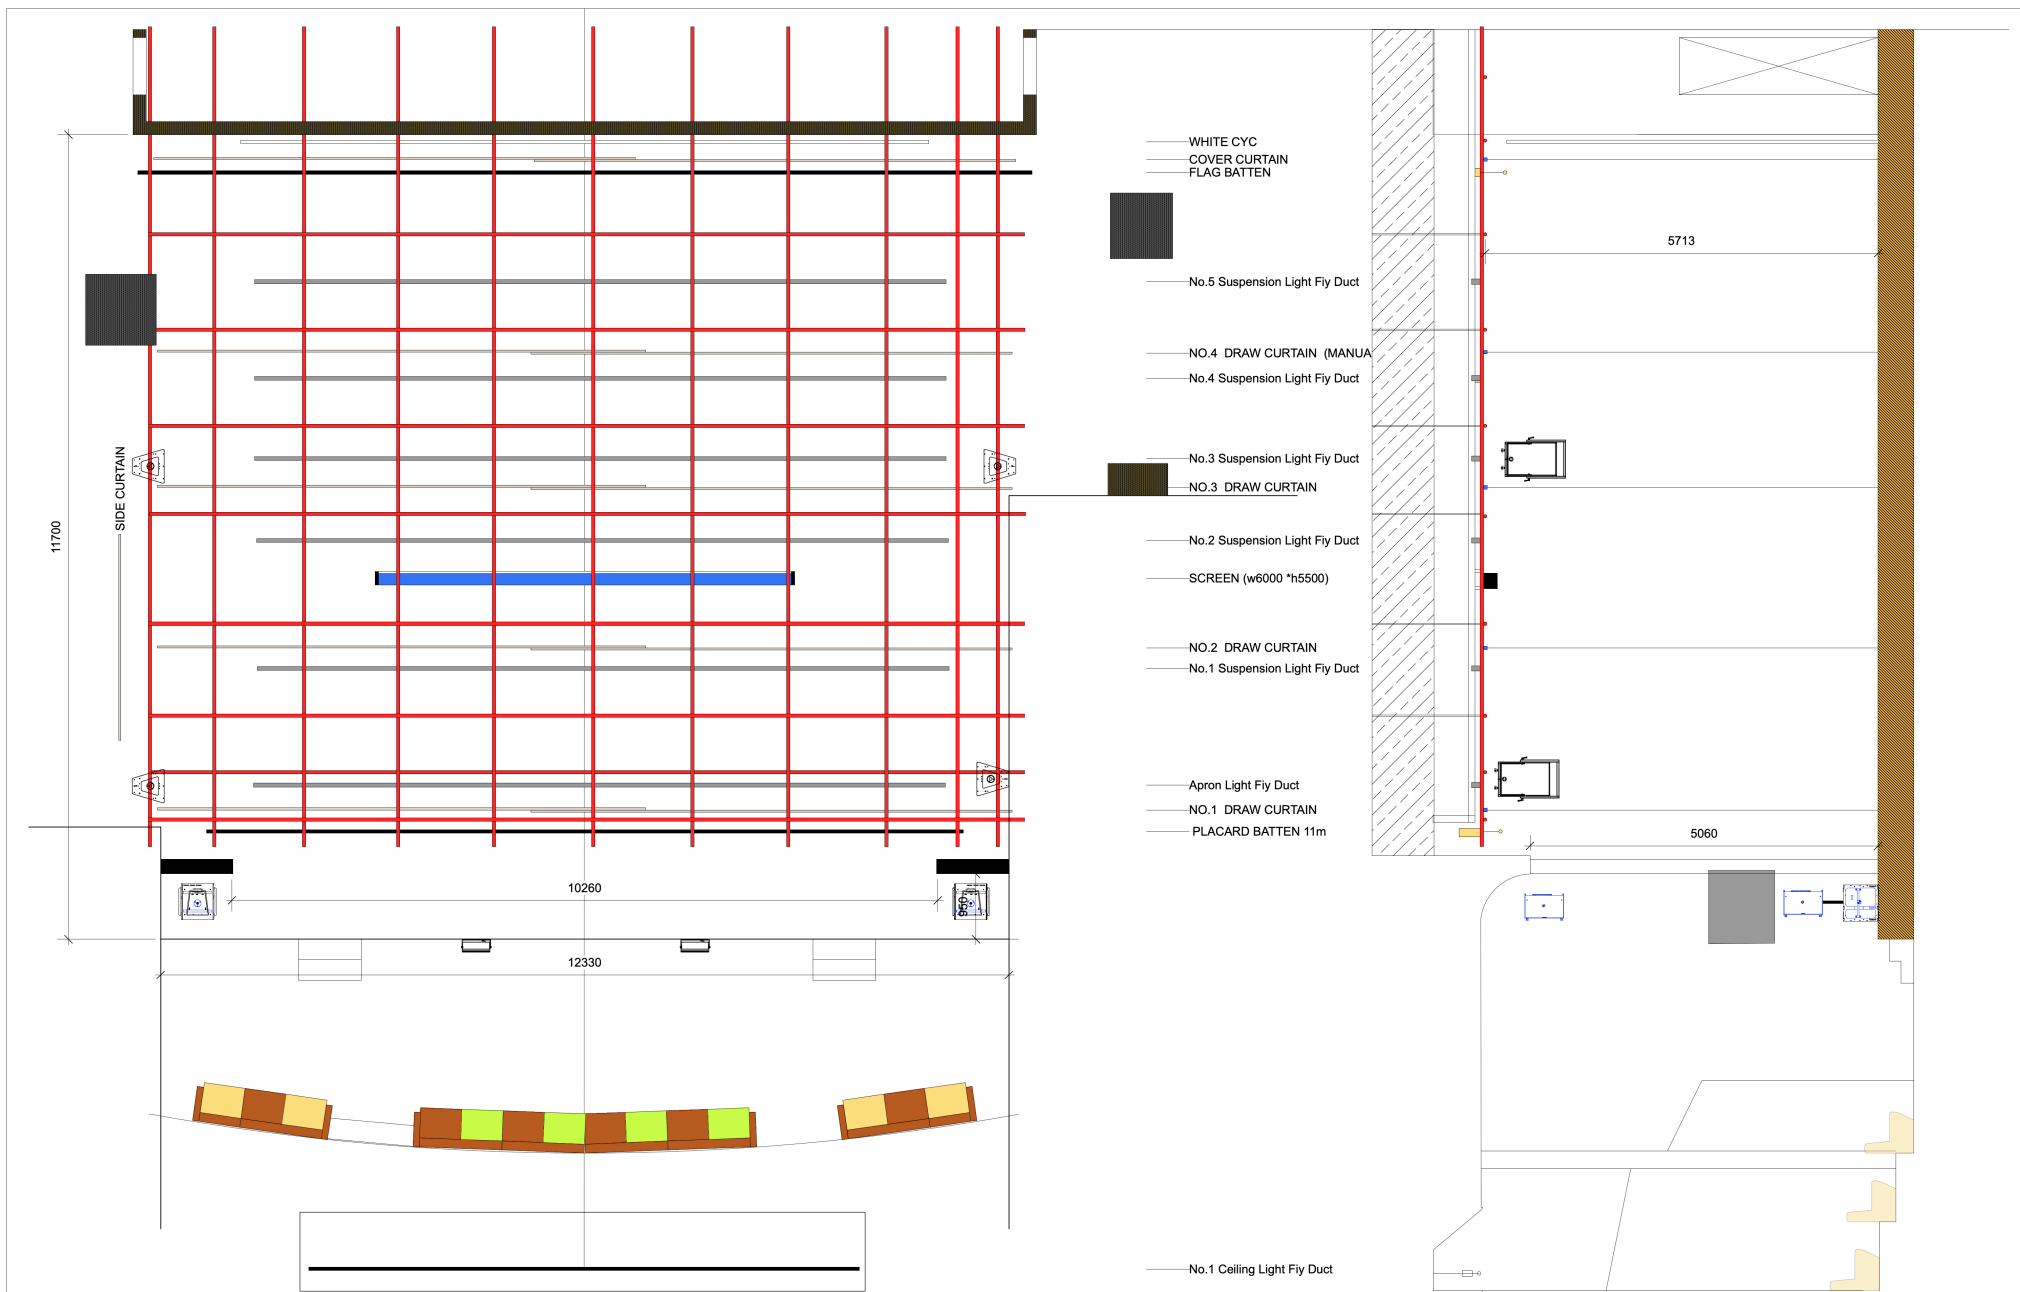

PROJECT TITLE	LOCATION	NOTE	DRAWING TITLE	SCALE	DRAWING BY	DRAWING NO.
	노원어린이극장		상부 평면도	Non	Nomess Stage	
				DATE		SHEET NO.
				2023.08.26		

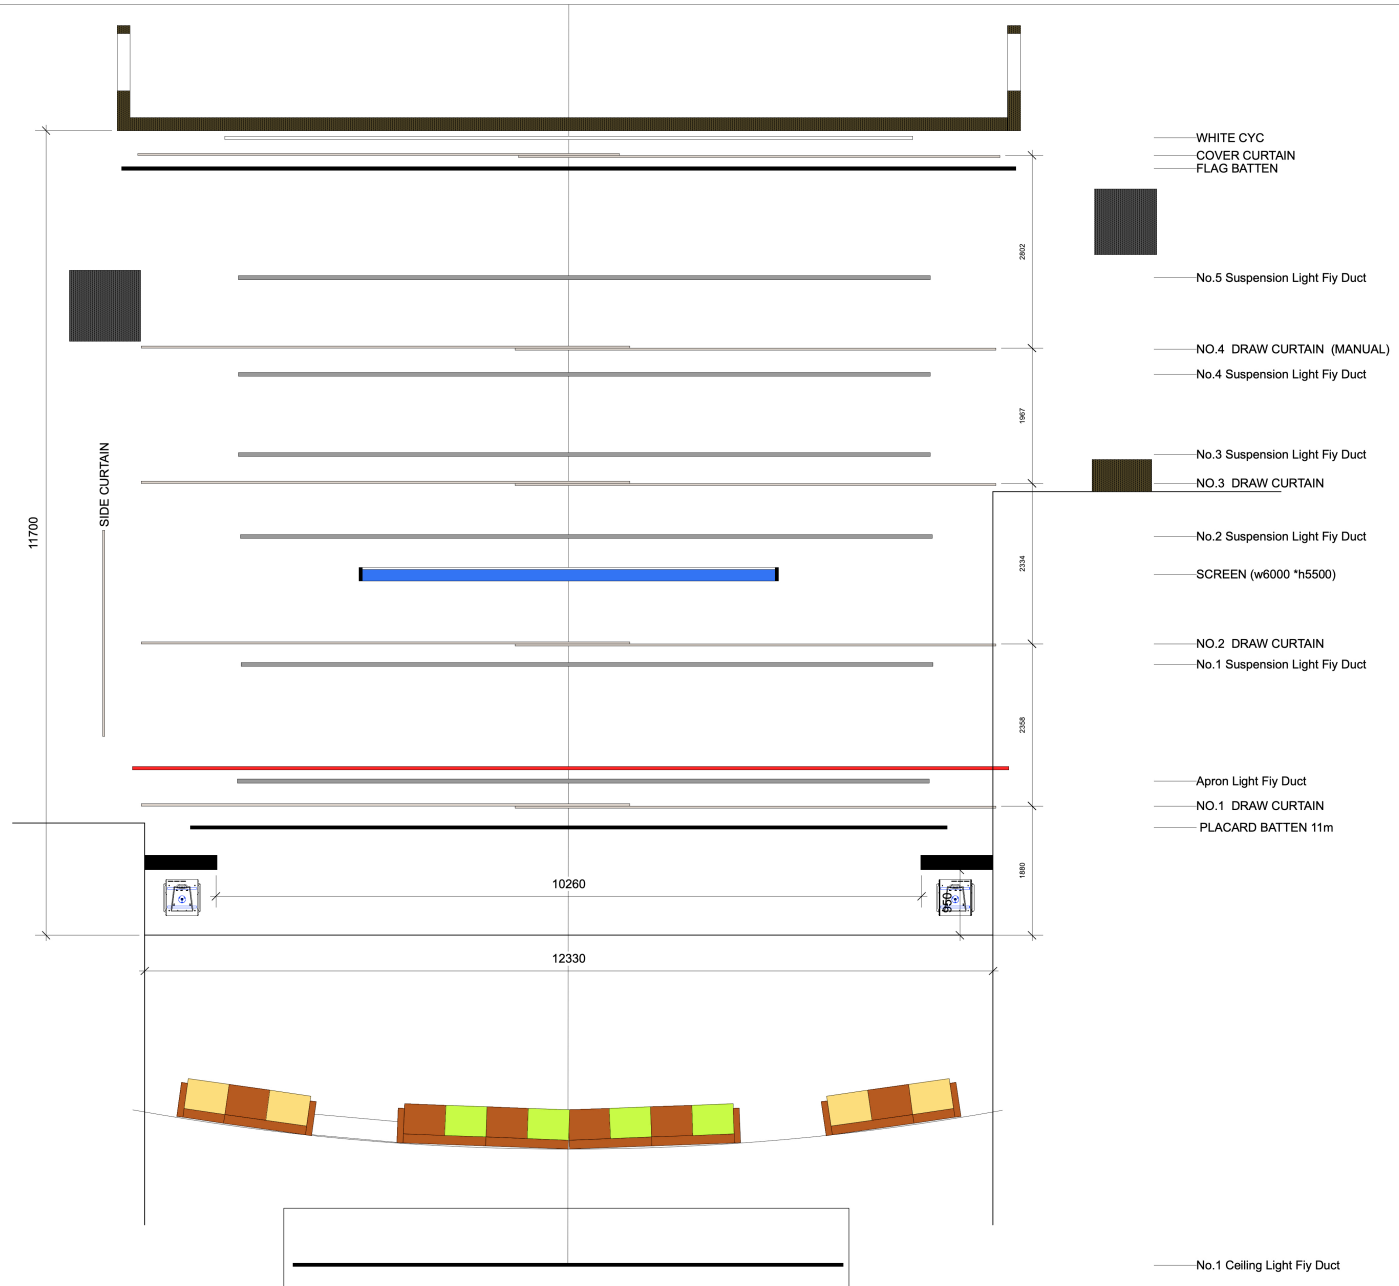

PROJECT TITLE	LOCATION	NOTE	DRAWING TITLE	SCALE	DRAWING BY	DRAWING NO.
				Non		
	노원어린이극장		상부 기계 평면도	DATE	Nomess Stage	SHEET NO.
				2023.08.26		

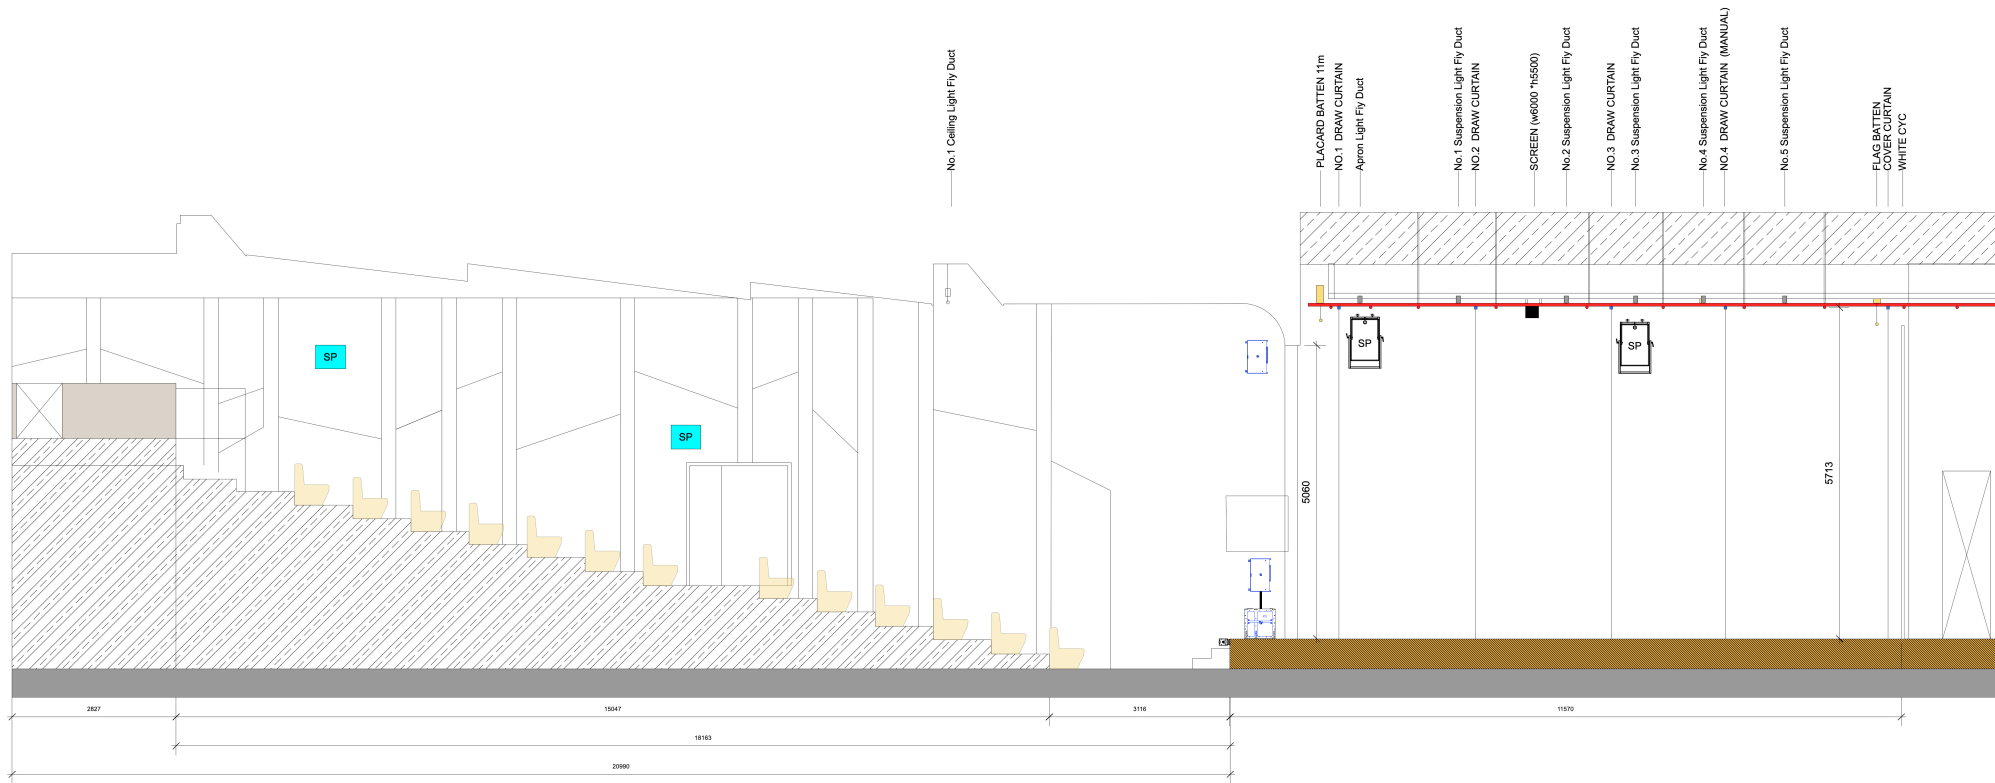

PROJECT TITLE	LOCATION	NOTE	DRAWING TITLE	SCALE	DRAWING BY	DRAWING NO.
	노원어린이극장		단면도	Non	Nomess Stage	
				DATE		SHEET NO.
				2023.08.26		

Wall Pocket #4

Wall Pocket #3

96 96  
95 95  
94 94  
DMX 19

93 93  
92 92  
91 91  
DMX 18

DMX 12 72 71 70 69 72 71 70 69 68 67 66 65 68 67 66 65 64 63 62 61 64 63 62 61 DMX 11

No.5 Suspension Light Fly Duct

DMX 10 60 59 58 57 60 59 58 57 56 55 54 53 56 55 54 53 52 51 50 49 52 51 50 49 DMX 9

No.4 Suspension Light Fly Duct

DMX 8 48 47 46 45 48 47 46 45 44 43 42 41 44 43 42 41 40 39 38 37 40 39 38 37 DMX 7

No.3 Suspension Light Fly Duct

DMX 6 36 35 34 33 36 35 34 33 32 31 30 29 32 31 30 29 28 27 26 25 28 27 26 25 DMX 5

No.2 Suspension Light Fly Duct

DMX 4 24 23 22 21 24 23 22 21 20 19 18 17 20 19 18 17 16 15 14 13 16 15 14 13 DMX 3

No.1 Suspension Light Fly Duct

DMX 2 12 11 10 9 12 11 10 9 8 7 6 5 8 7 6 5 4 3 2 1 4 3 2 1 DMX 1

Apron Light Fly Duct

DMX 18  
87 87  
86 86  
85 85

Wall Pocket #1

DMX 17  
90 90  
89 89  
88 88

Wall Pocket #2

SIDE CURTAIN

스텝사유식

DMX 14

82 81 80 79 78 82 81 80 79 78 77 76 75 74 73 77 76 75 74 73

DMX 13


No.1 Ceiling Light Fly Duct

DMX 15-2

84 83 84 83 84 83





DMX 15-1

No.2 Ceiling Light Fly Duct

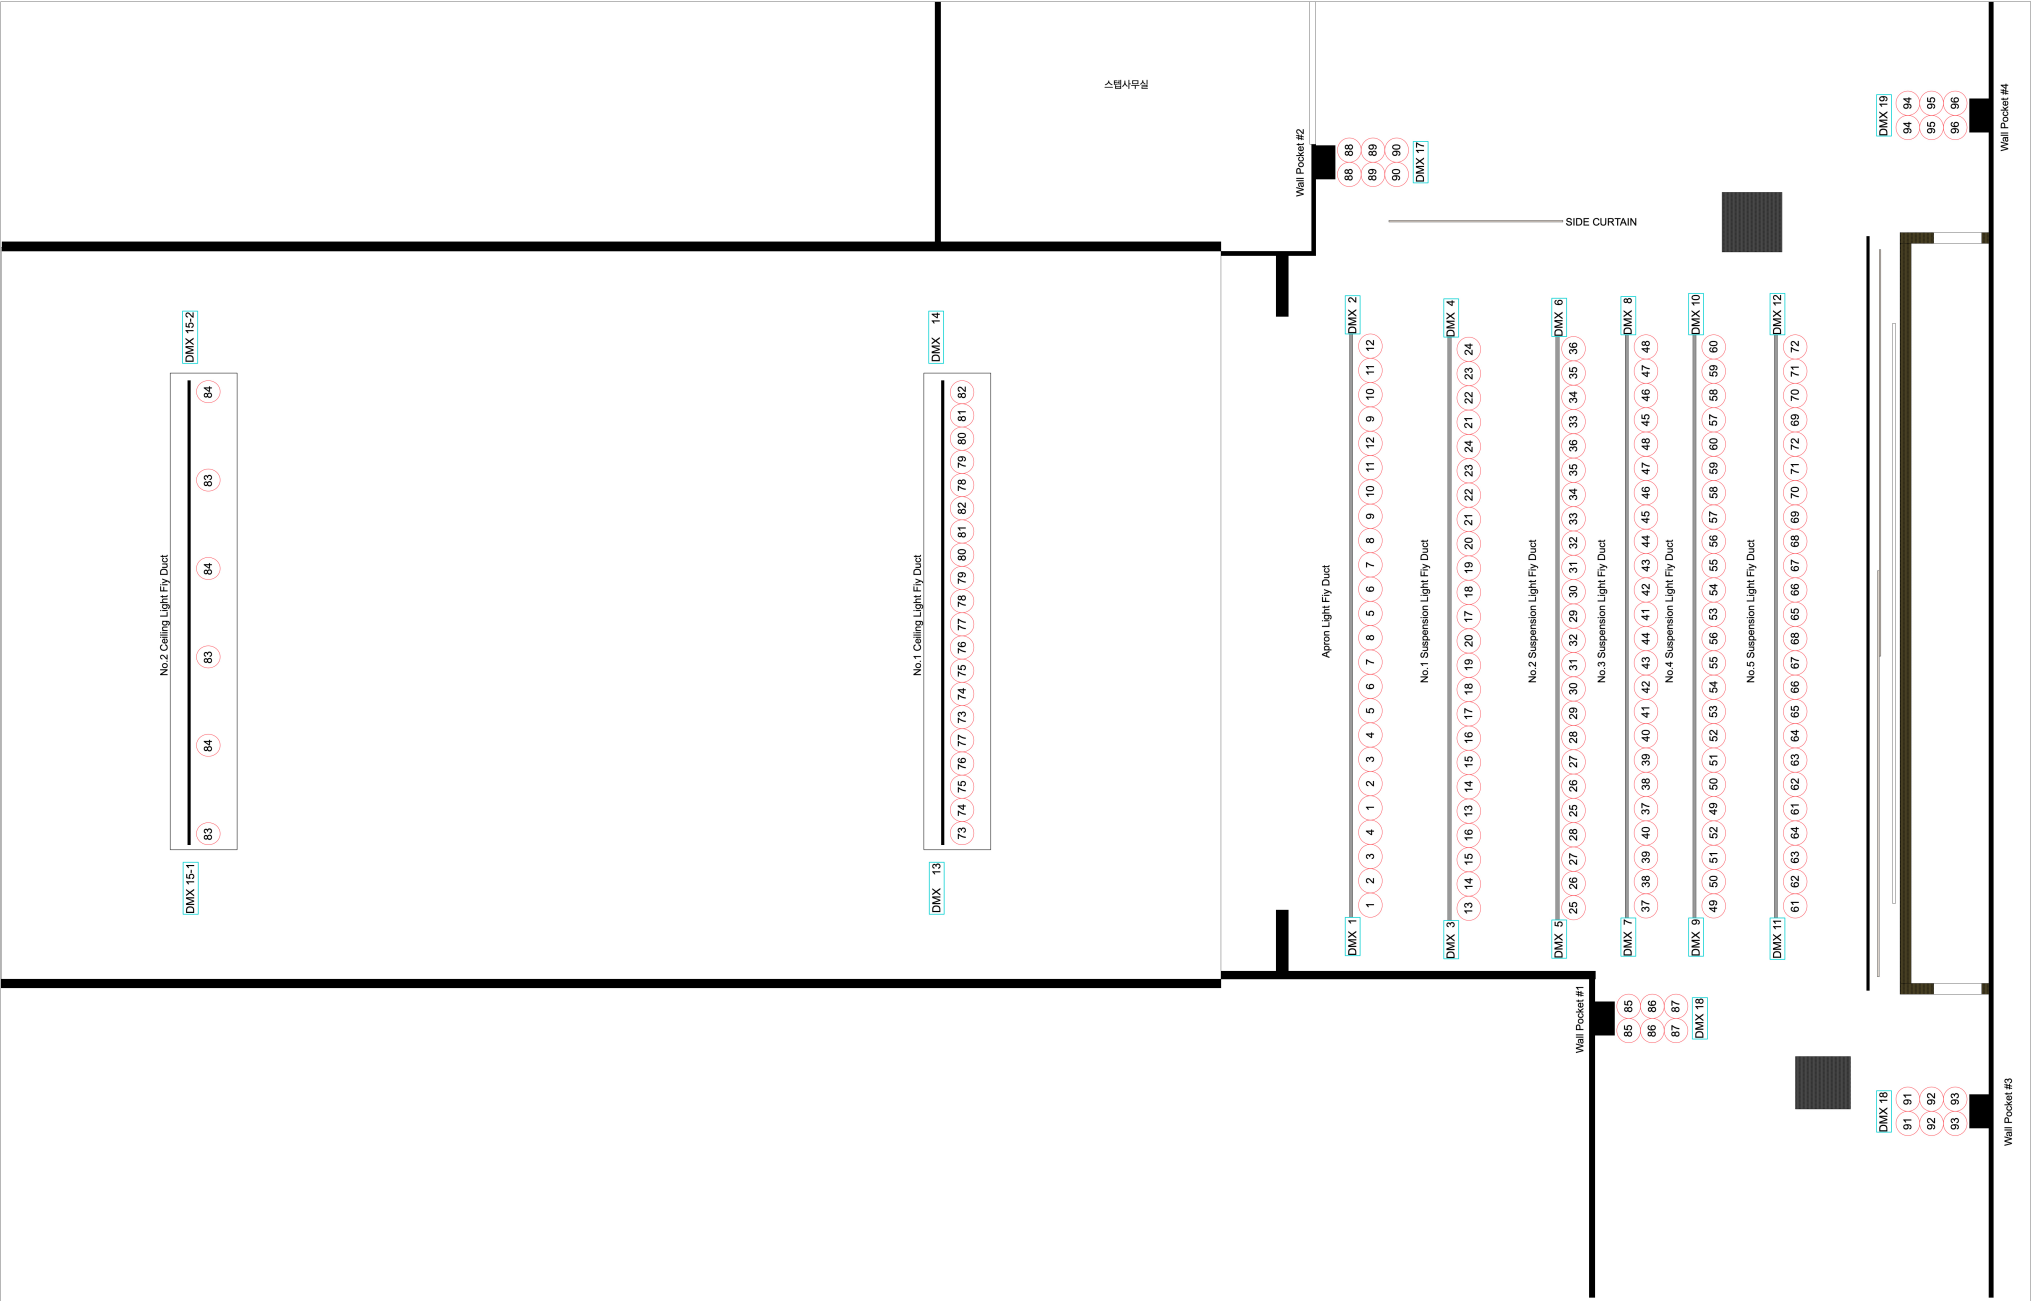


PROJECT TITLE	LOCATION 노원어린이극장	NOTE	DRAWING TITLE 조명회로도	SCALE Non	DRAWING BY Noness Stage	DRAWING NO.
				DATE 2023.08.26		SHEET NO.

MAIN SPEAKER	Meyer Sound ULTRA-X40 × 4EA (1EA × 4Point)
SUB WOOPER SPEAKER	Meyer Sound 750-LFC × 2EA (1EA × 2Point)
CENTER SPEAKER	Meyer Sound ULTRA-X40 × 1EA
FRONT FILL SPEAKER	Meyer Sound UP-4Slim × 2EA (1EA × 2Point)
SIDE FILL SPEAKER	Meyer Sound UPQ-1P × 4EA (1EA × 4Point)
SURROUND SPEAKER	Meyer Sound CSR210A × 4EA (1EA × 4Point)

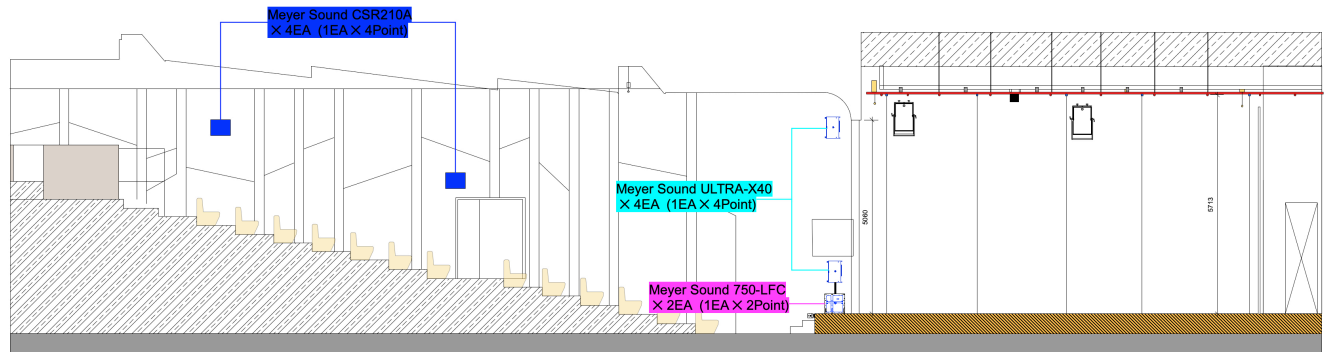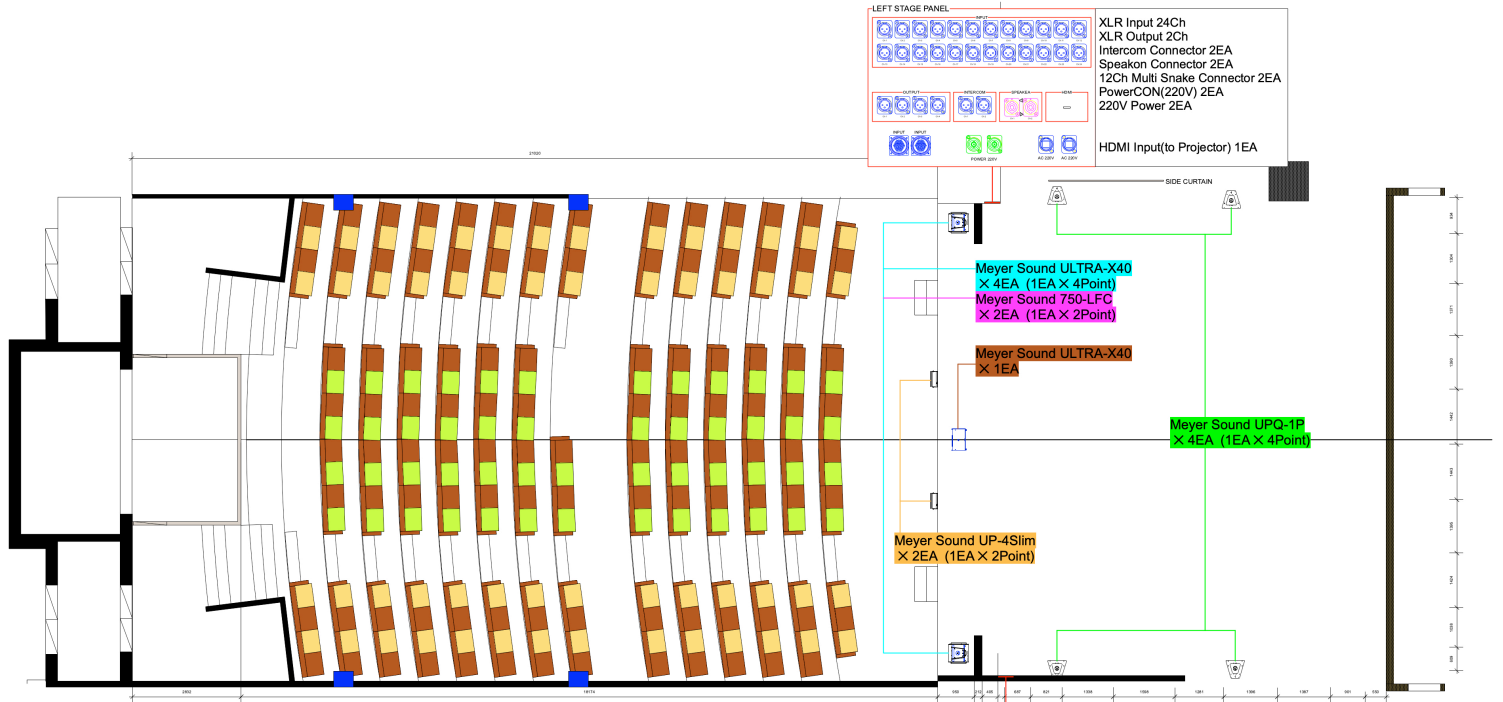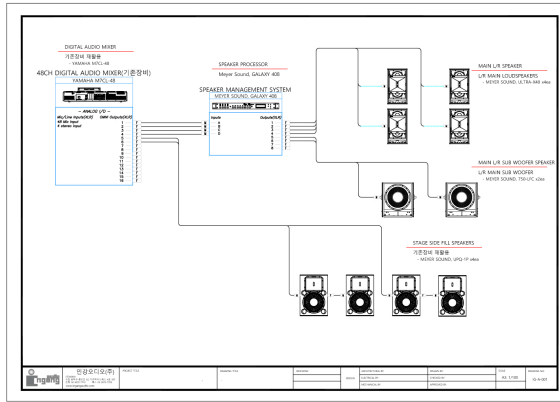
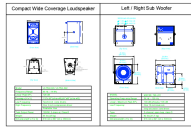


PROJECT TITLE	LOCATION	NOTE	DRAWING TITLE	SCALE	DRAWING BY	DRAWING NO.
	노원어린이극장		음향 도면	Non	Nomess Stage	
				DATE		SHEET NO.
				2023.08.26		

## LEFT STAGE PANEL

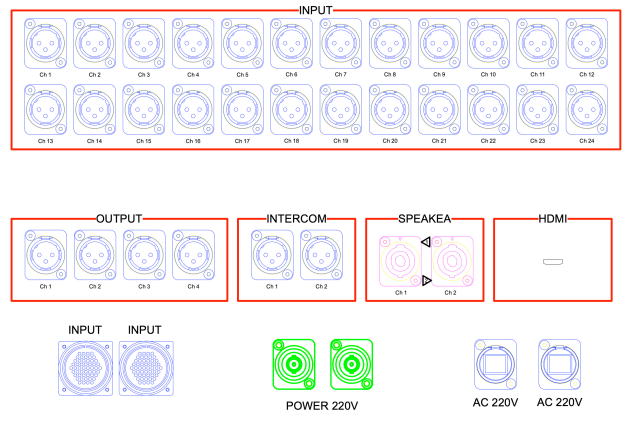

## RIGHT STAGE PANEL

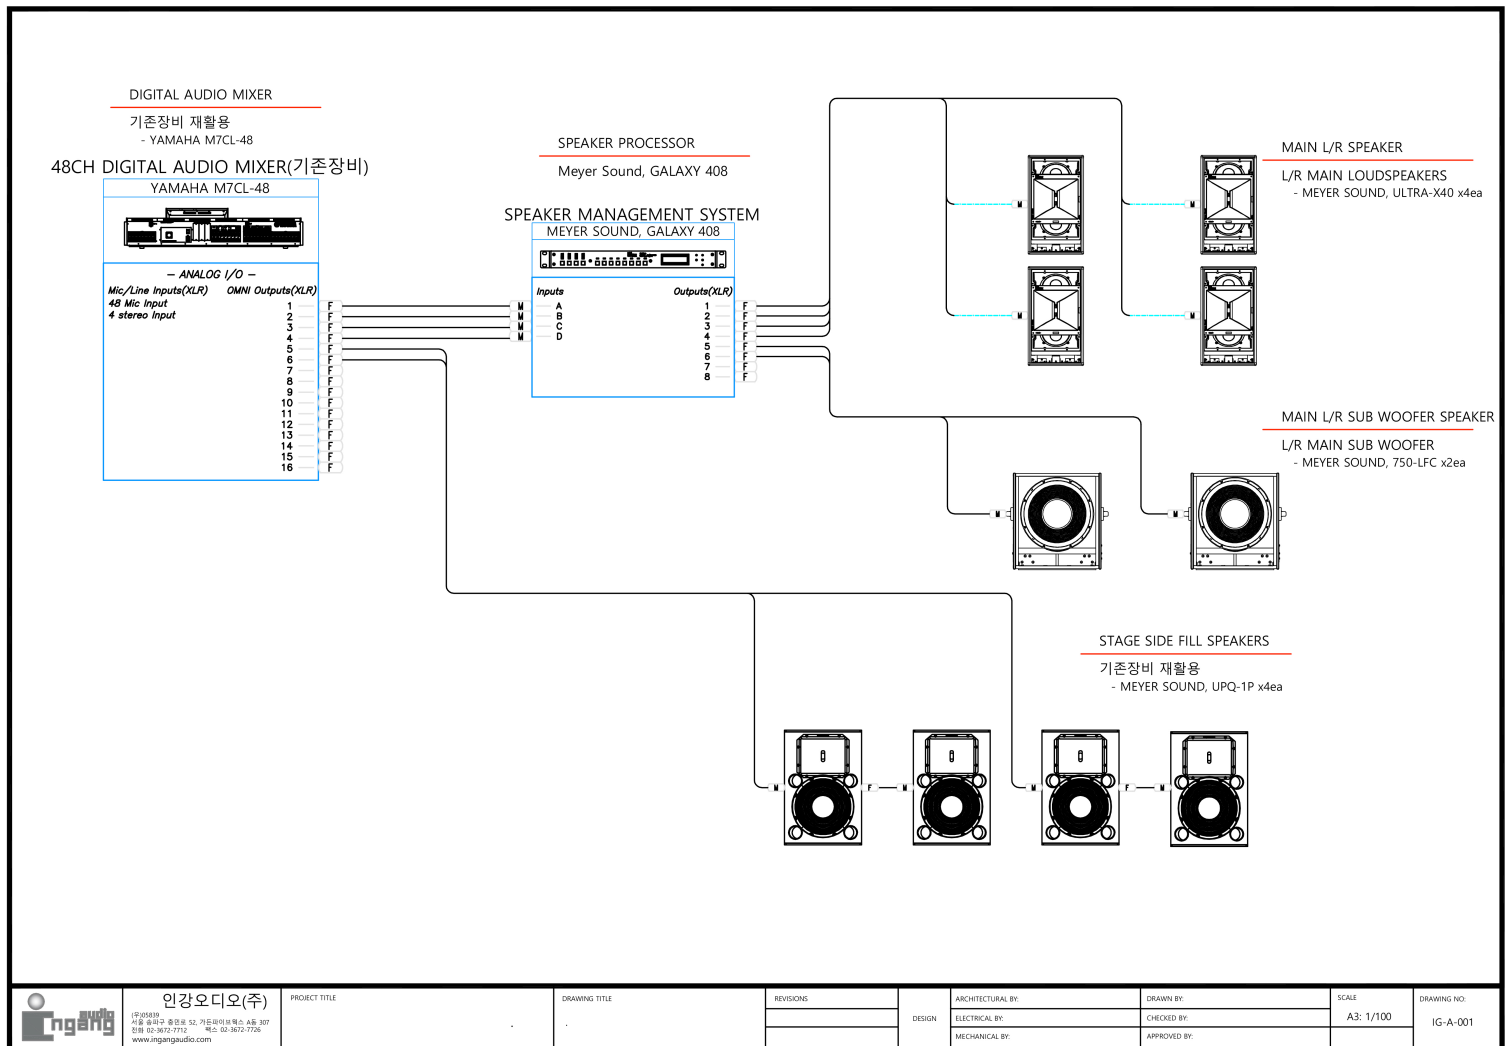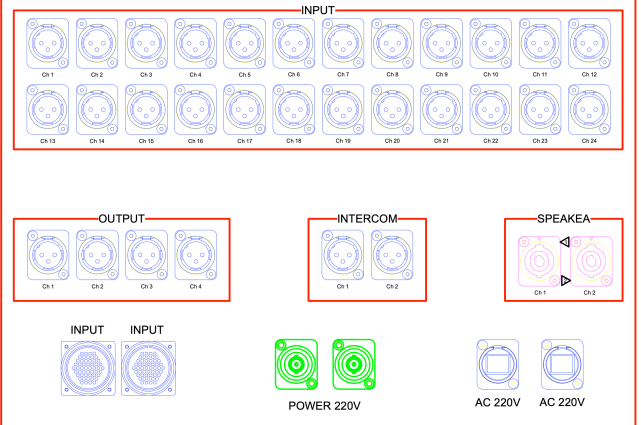

인강오디오(주)

서울특별시 강남구 테헤란로 52, 5층 (인강오디오빌딩 5층 507호)  
전화: 02-3875-7775, 02-3875-7776  
www.ingaudio.com

PROJECT TITLE

DRAWING TITLE

REVISIONS

DESIGN

ARCHITECTURAL BY:

ELECTRICAL BY:

MECHANICAL BY:

DRAWN BY:

CHECKED BY:

APPROVED BY:

SCALE

A3: 1/100

DRAWING NO.

IG-A-001